


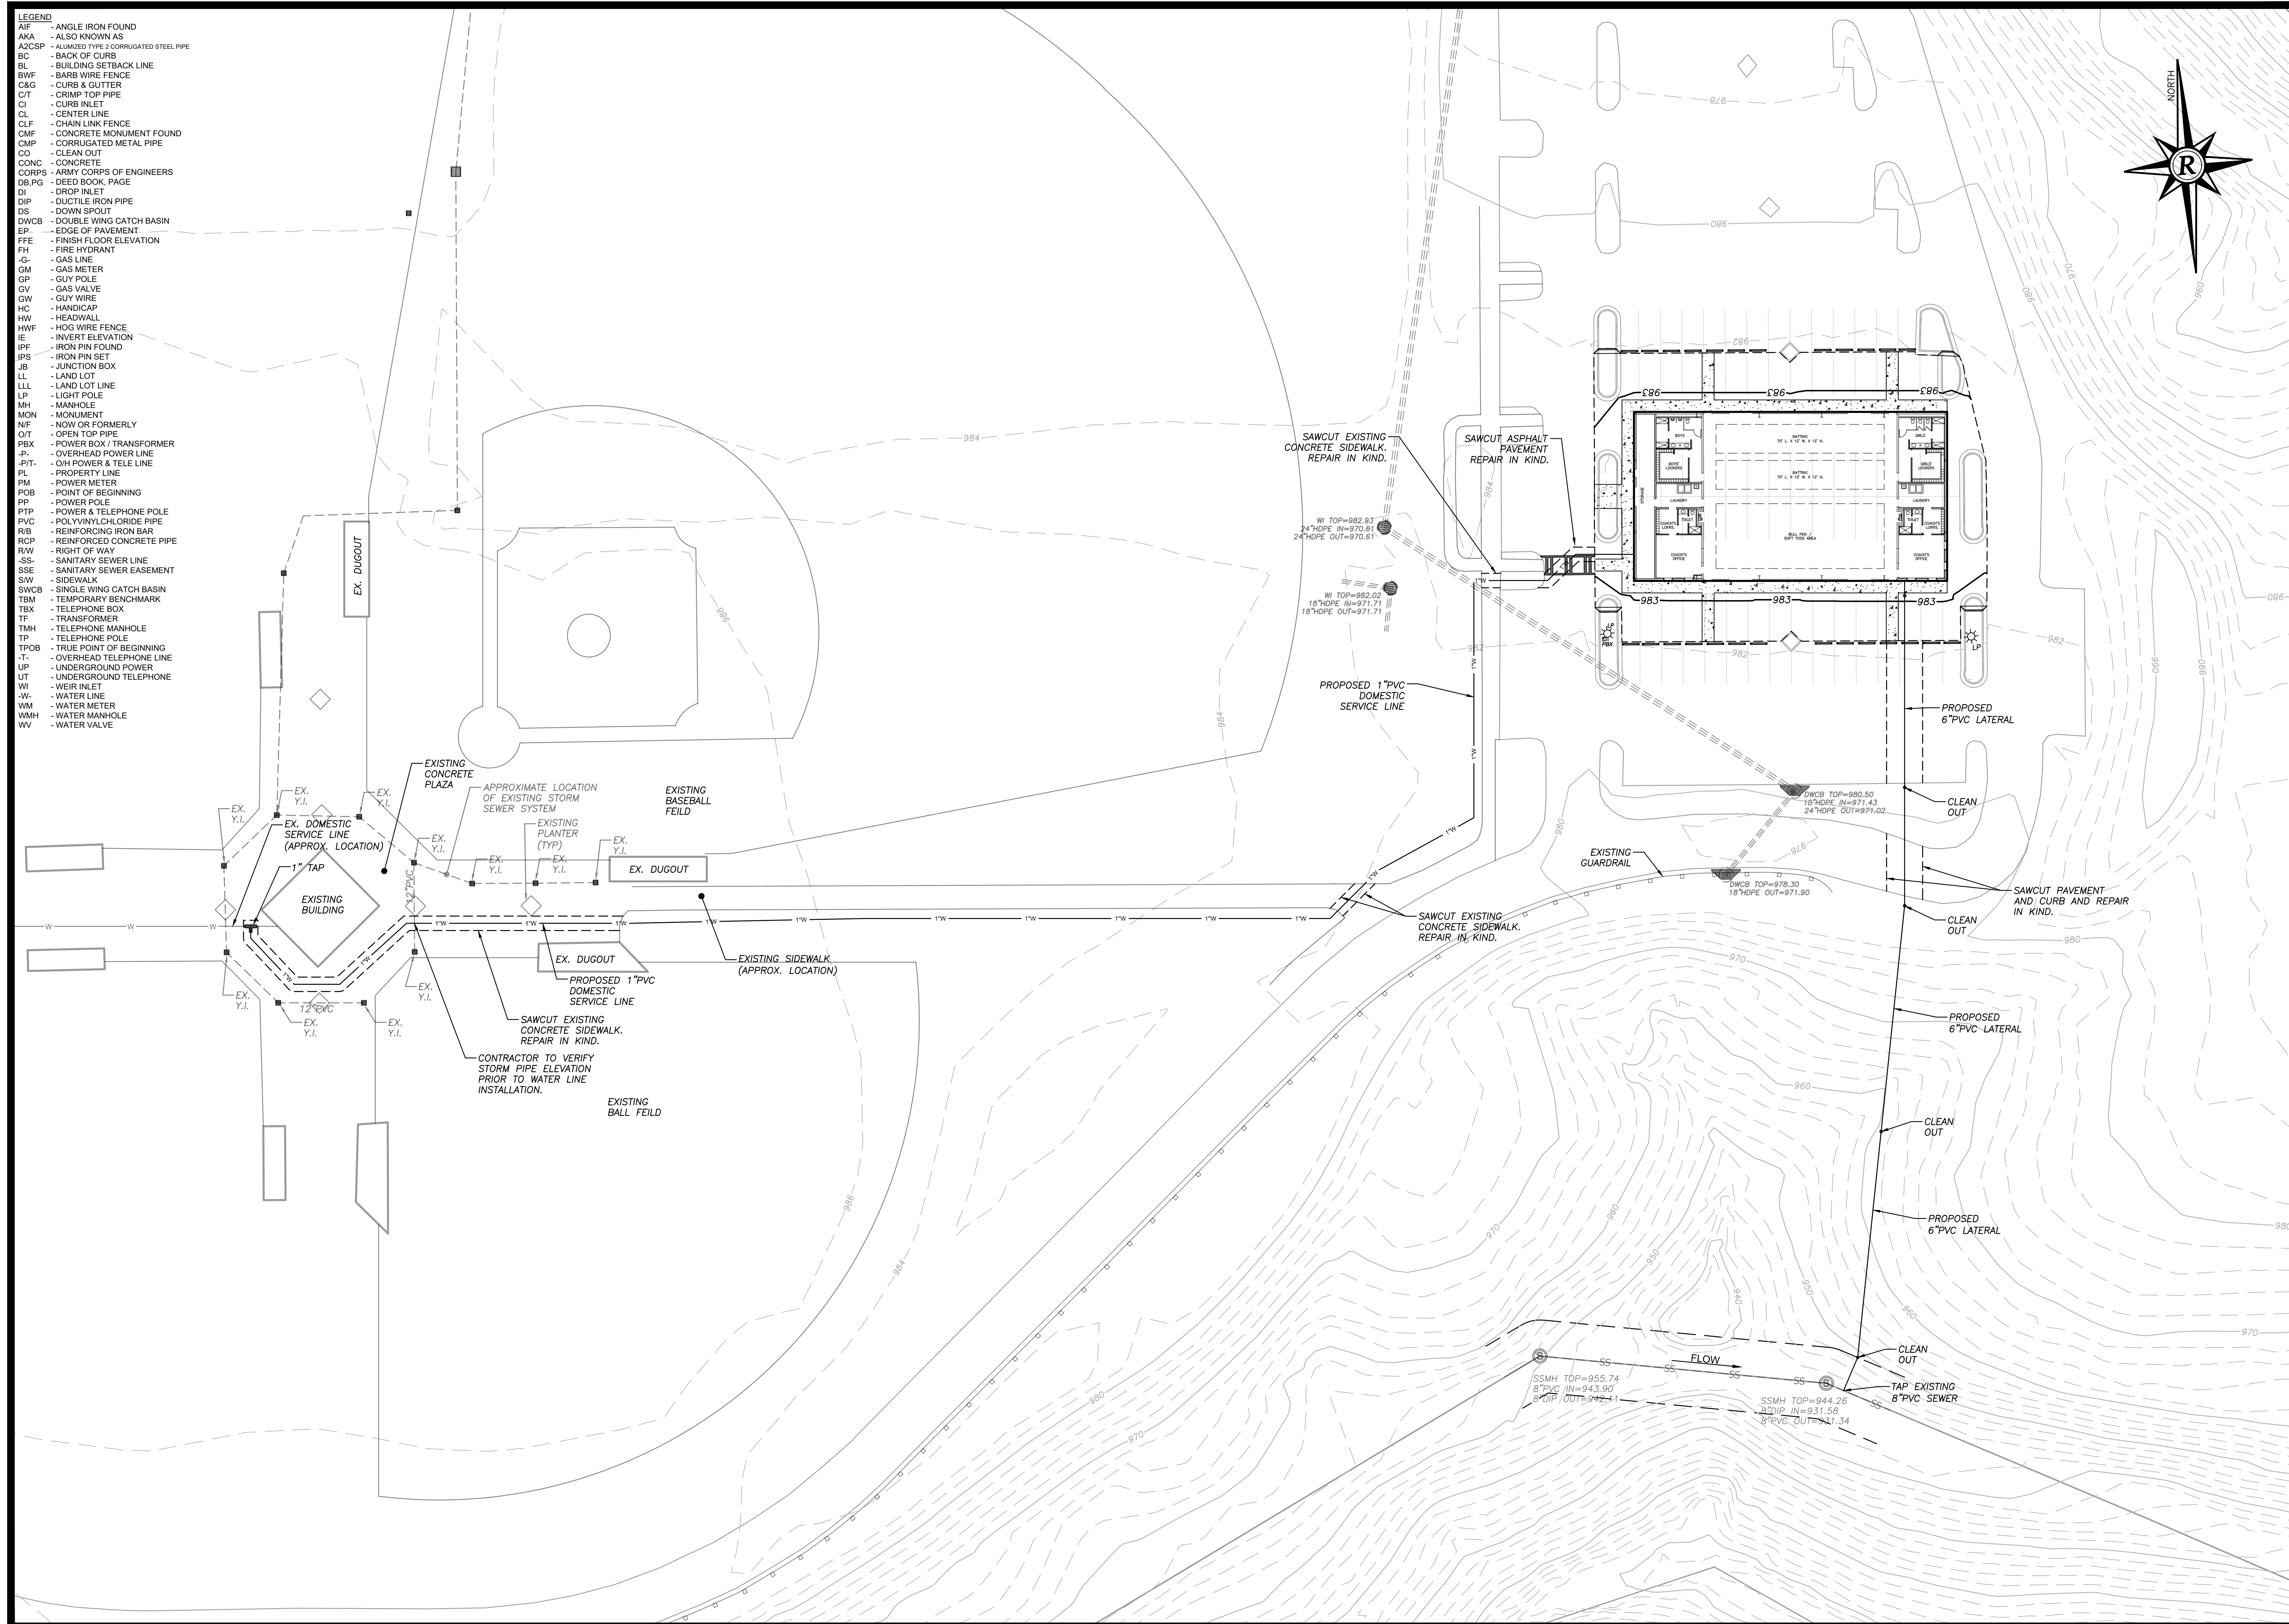

Rochester
& Associates, Inc.

425 Oak Street N.W. • Gainesville, Georgia 30501
(770)718.0600 (770)718.9090 Fax • www.rochesterassoc.com

OVERALL SITE & UTILITY PLAN
FOR:
**CHEROKEE BLUFFS
HIGH SCHOOL**
LOCATED IN
CITY OF FLOWERY BRANCH
HALL COUNTY, GEORGIA

[illegible]

ANY CHANGES OR ALTERATIONS MADE TO THESE CONSTRUCTION DRAWINGS WITHOUT THE WRITTEN APPROVAL OF THE REGISTERED PROFESSIONAL ENGINEER OR ARCHITECT ASSOCIATES INC. Voids, the section showing where the original drawings were made and any changes are kept on file for verification of any changes.

GRAPHIC SCALE


15' 0' 30' 60'



- LEGEND
- ANGLE IRON FOUND
 - AKA - ALSO KNOWN AS
 - AZCSP - ALUMINIZED TYPE 2 CORRUGATED STEEL PIPE
 - BC - BACK OF CURB
 - BL - BUILDING SETBACK LINE
 - BWF - BARB WIRE FENCE
 - C&G - CURB & GUTTER
 - CT - CRIMP TOP PIPE
 - CI - CURB INLET
 - CL - CENTER LINE
 - CLF - CHAIN LINK FENCE
 - CMF - CONCRETE MONUMENT FOUND
 - CMP - CORRUGATED METAL PIPE
 - CO - CLEAN OUT
 - CONC - CONCRETE
 - CORPS - ARMY CORPS OF ENGINEERS
 - DB,PG - DEED BOOK, PAGE
 - DI - DROP INLET
 - DIP - DUCTILE IRON PIPE
 - DS - DOWN SPOUT
 - DWCB - DOUBLE WING CATCH BASIN
 - EP - EDGE OF PAVEMENT
 - FFE - FINISH FLOOR ELEVATION
 - FH - FIRE HYDRANT
 - G - GAS LINE
 - GM - GAS METER
 - GP - GUY POLE
 - GV - GAS VALVE
 - GW - GUY WIRE
 - HC - HANDICAP
 - HW - HEADWALL
 - HWF - HOG WIRE FENCE
 - IE - INVERT ELEVATION
 - IPF - IRON PIN FOUND
 - IPS - IRON PIN SET
 - JB - JUNCTION BOX
 - LL - LAND LOT
 - LLL - LAND LOT LINE
 - LP - LIGHT POLE
 - MH - MANHOLE
 - MON - MONUMENT
 - NF - NOW OR FORMERLY
 - OIT - OPEN TOP PIPE
 - PBX - POWER BOX / TRANSFORMER
 - P - OVERHEAD POWER LINE
 - PIT - OIL POWER & TELE LINE
 - PL - PROPERTY LINE
 - PM - POWER METER
 - POB - POINT OF BEGINNING
 - PP - POWER POLE
 - PTP - POWER & TELEPHONE POLE
 - PVC - POLYVINYLCHLORIDE PIPE
 - RB - REINFORCING IRON BAR
 - RCP - REINFORCED CONCRETE PIPE
 - R/W - RIGHT OF WAY
 - SS - SANITARY SEWER LINE
 - SSE - SANITARY SEWER EASEMENT
 - S/W - SIDEWALK
 - SWCB - SINGLE WING CATCH BASIN
 - TBM - TEMPORARY BENCHMARK
 - TBX - TELEPHONE BOX
 - TF - TRANSFORMER
 - TMH - TELEPHONE MANHOLE
 - TP - TELEPHONE POLE
 - TPOB - TRUE POINT OF BEGINNING
 - T - OVERHEAD TELEPHONE LINE
 - UP - UNDERGROUND POWER
 - UT - UNDERGROUND TELEPHONE
 - WI - WEIR INLET
 - W - WATER LINE
 - WM - WATER METER
 - WMH - WATER MANHOLE
 - WV - WATER VALVE

WI TOP=982.93
"HDPE IN=970.61
DPE OUT=970.61

WI TOP=982.02
"8"HDPE IN=971.71
"HDPE OUT=971.71

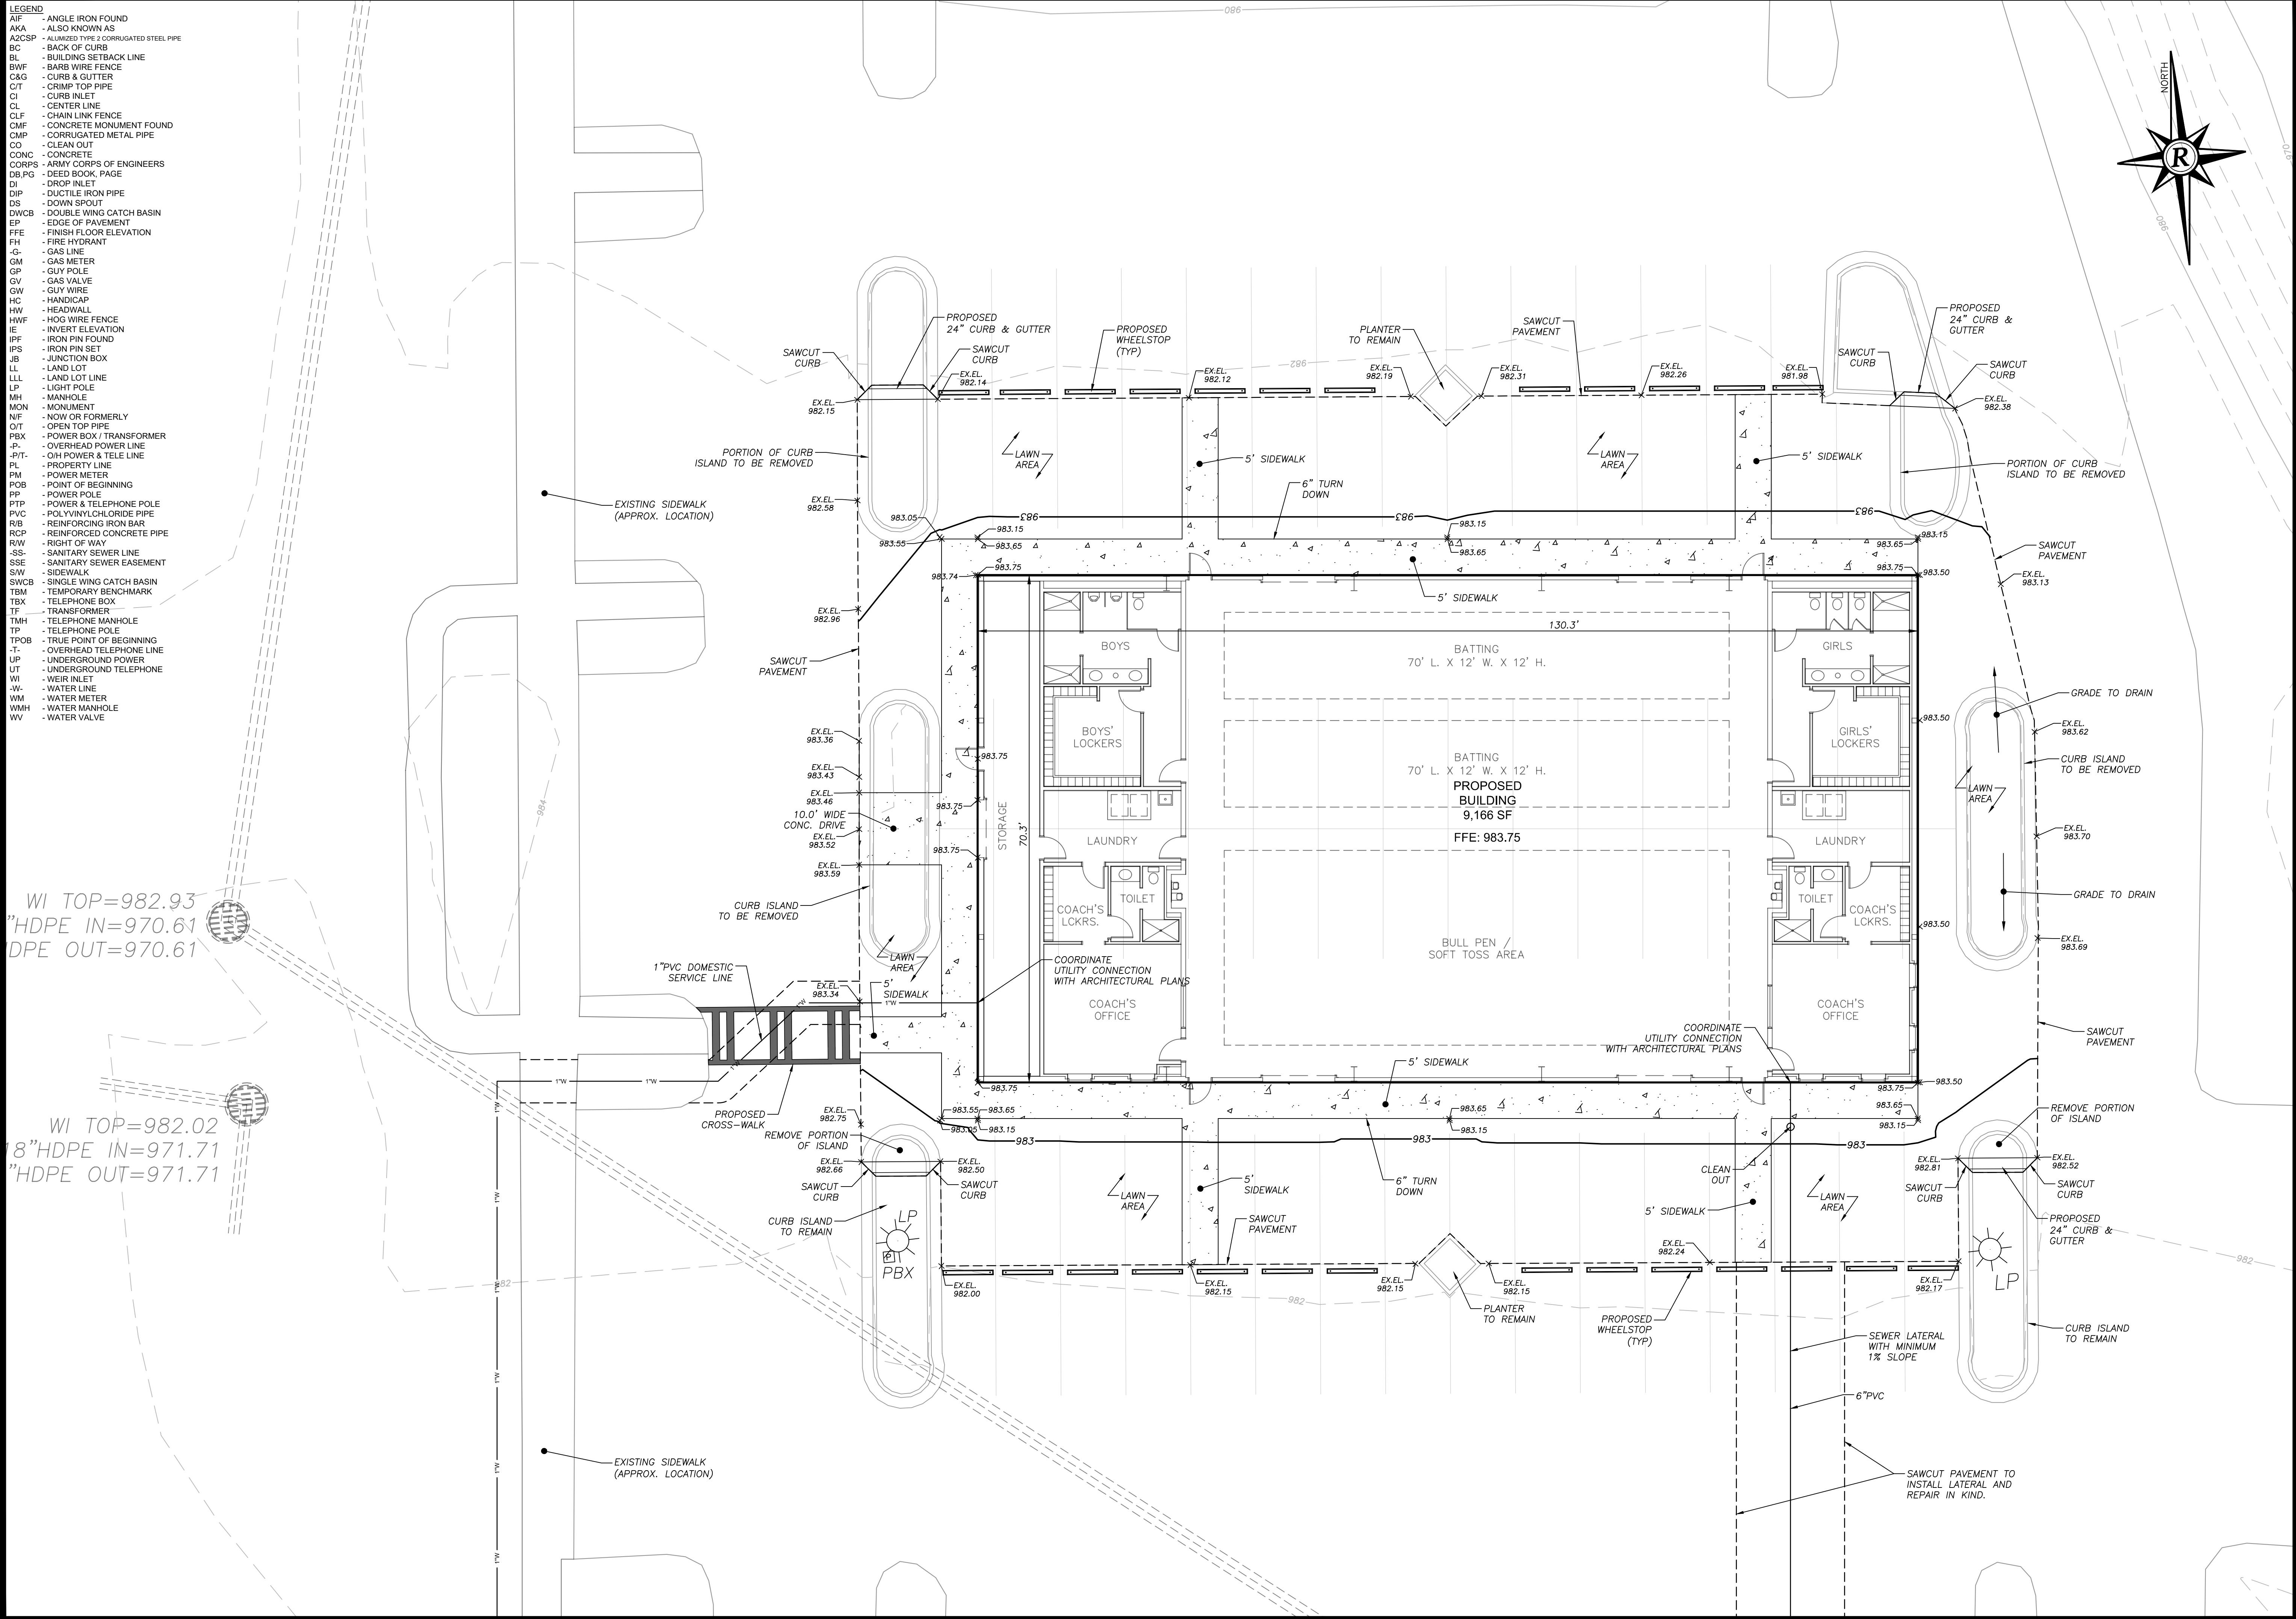

Rochester & Associates, Inc.
425 Oak Street N.W. • Gainesville, Georgia 30501
(770)718.0600 (770)718.9090 Fax • www.rochester-assoc.com

FOR:
**CHEROKEE BLUFFS
HIGH SCHOOL**
LOCATED IN
CITY OF FLOWERY BRANCH
HALL COUNTY, GEORGIA

REVISIONS		NO.	DATE	DESCRIPTION

ANY CHANGES OR ALTERATIONS MADE TO THIS DRAWING SHALL BE THE RESPONSIBILITY OF THE CLIENT. THE WRITTEN APPROVAL OF ROCHESTER & ASSOCIATES, INC. IS REQUIRED FOR ANY CHANGES TO BE MADE TO THIS DRAWING. THE ORIGINAL DRAWINGS SHALL BE KEPT IN THE PROJECT FILE FOR VERIFICATION OF ANY CHANGES.

GRAPHIC SCALE
5' 0' 10' 20'

SHEET
2
OF
2

DATE: 1/22/2019
SCALE: 1"=10'
JOB NO: 143-PRP
DRAWN BY: ATM